


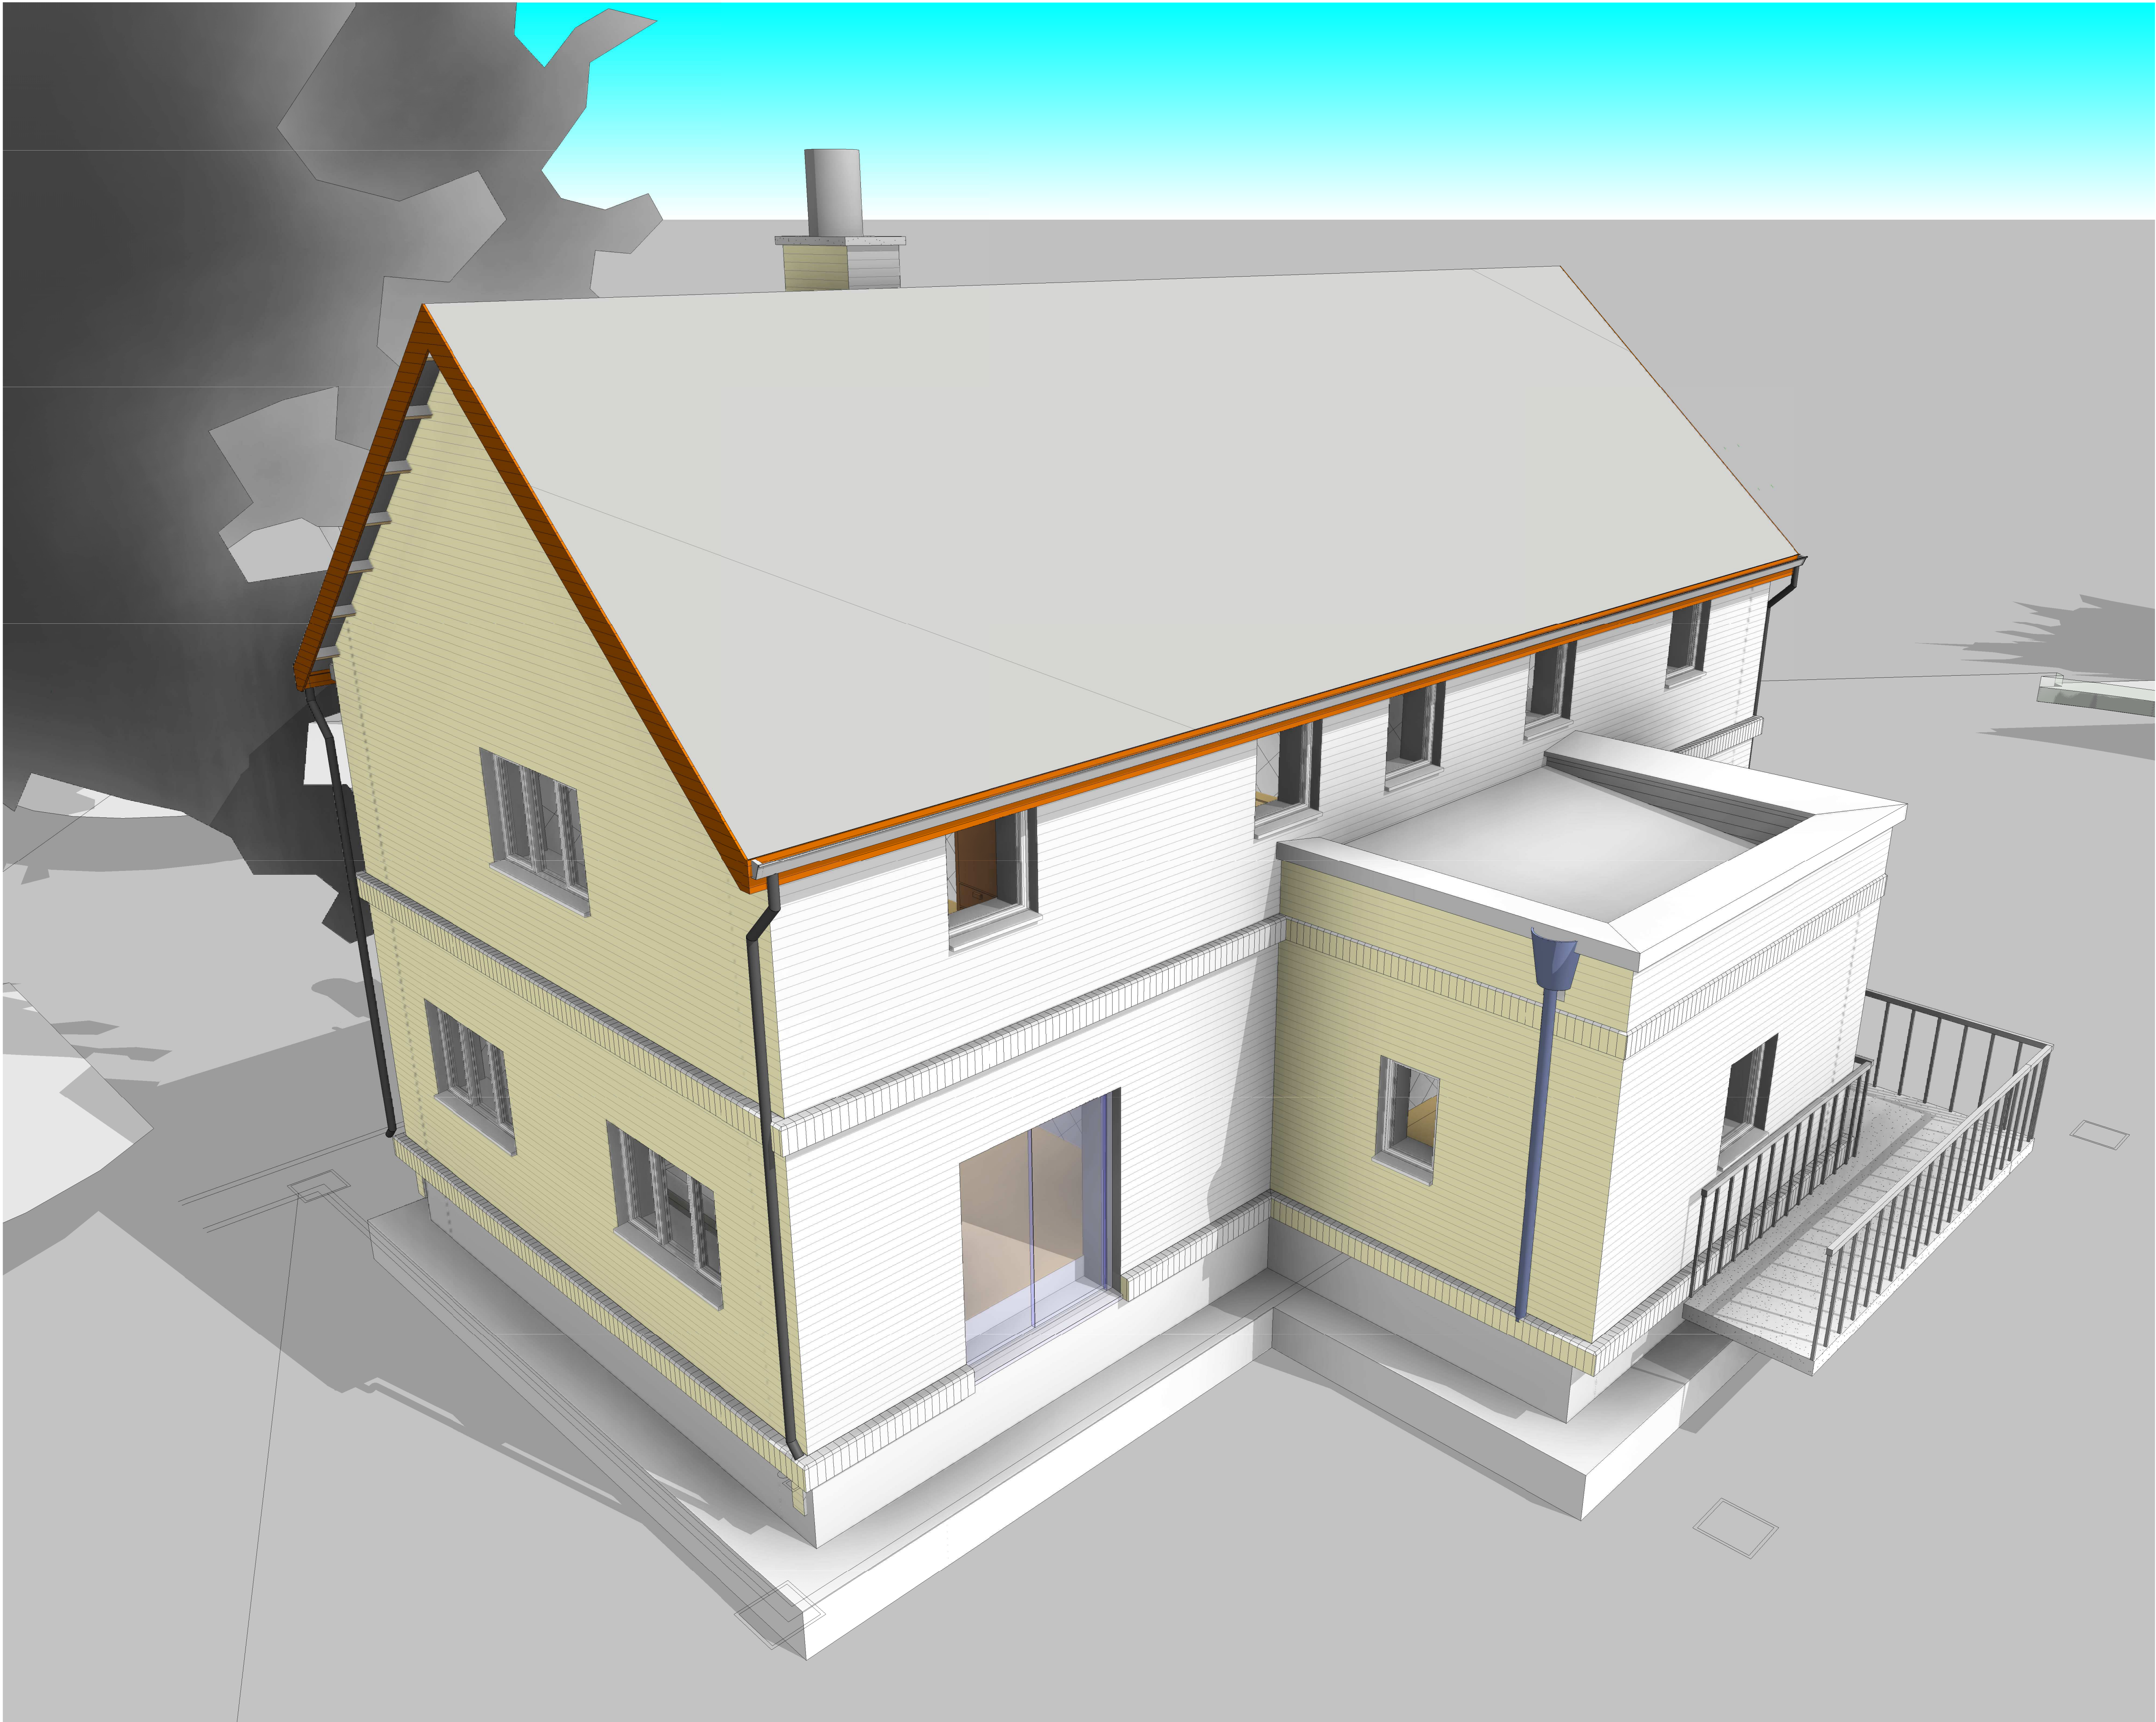

DT175 - 01
GENERAL
ARRANGEMENT
DRAWINGS

3D Render

Project number **PROJECT 7**



Date **24 April 2017**

Drawn by **Kevin Murphy**

Checked by **Checker**

A100

Scale

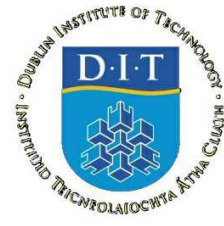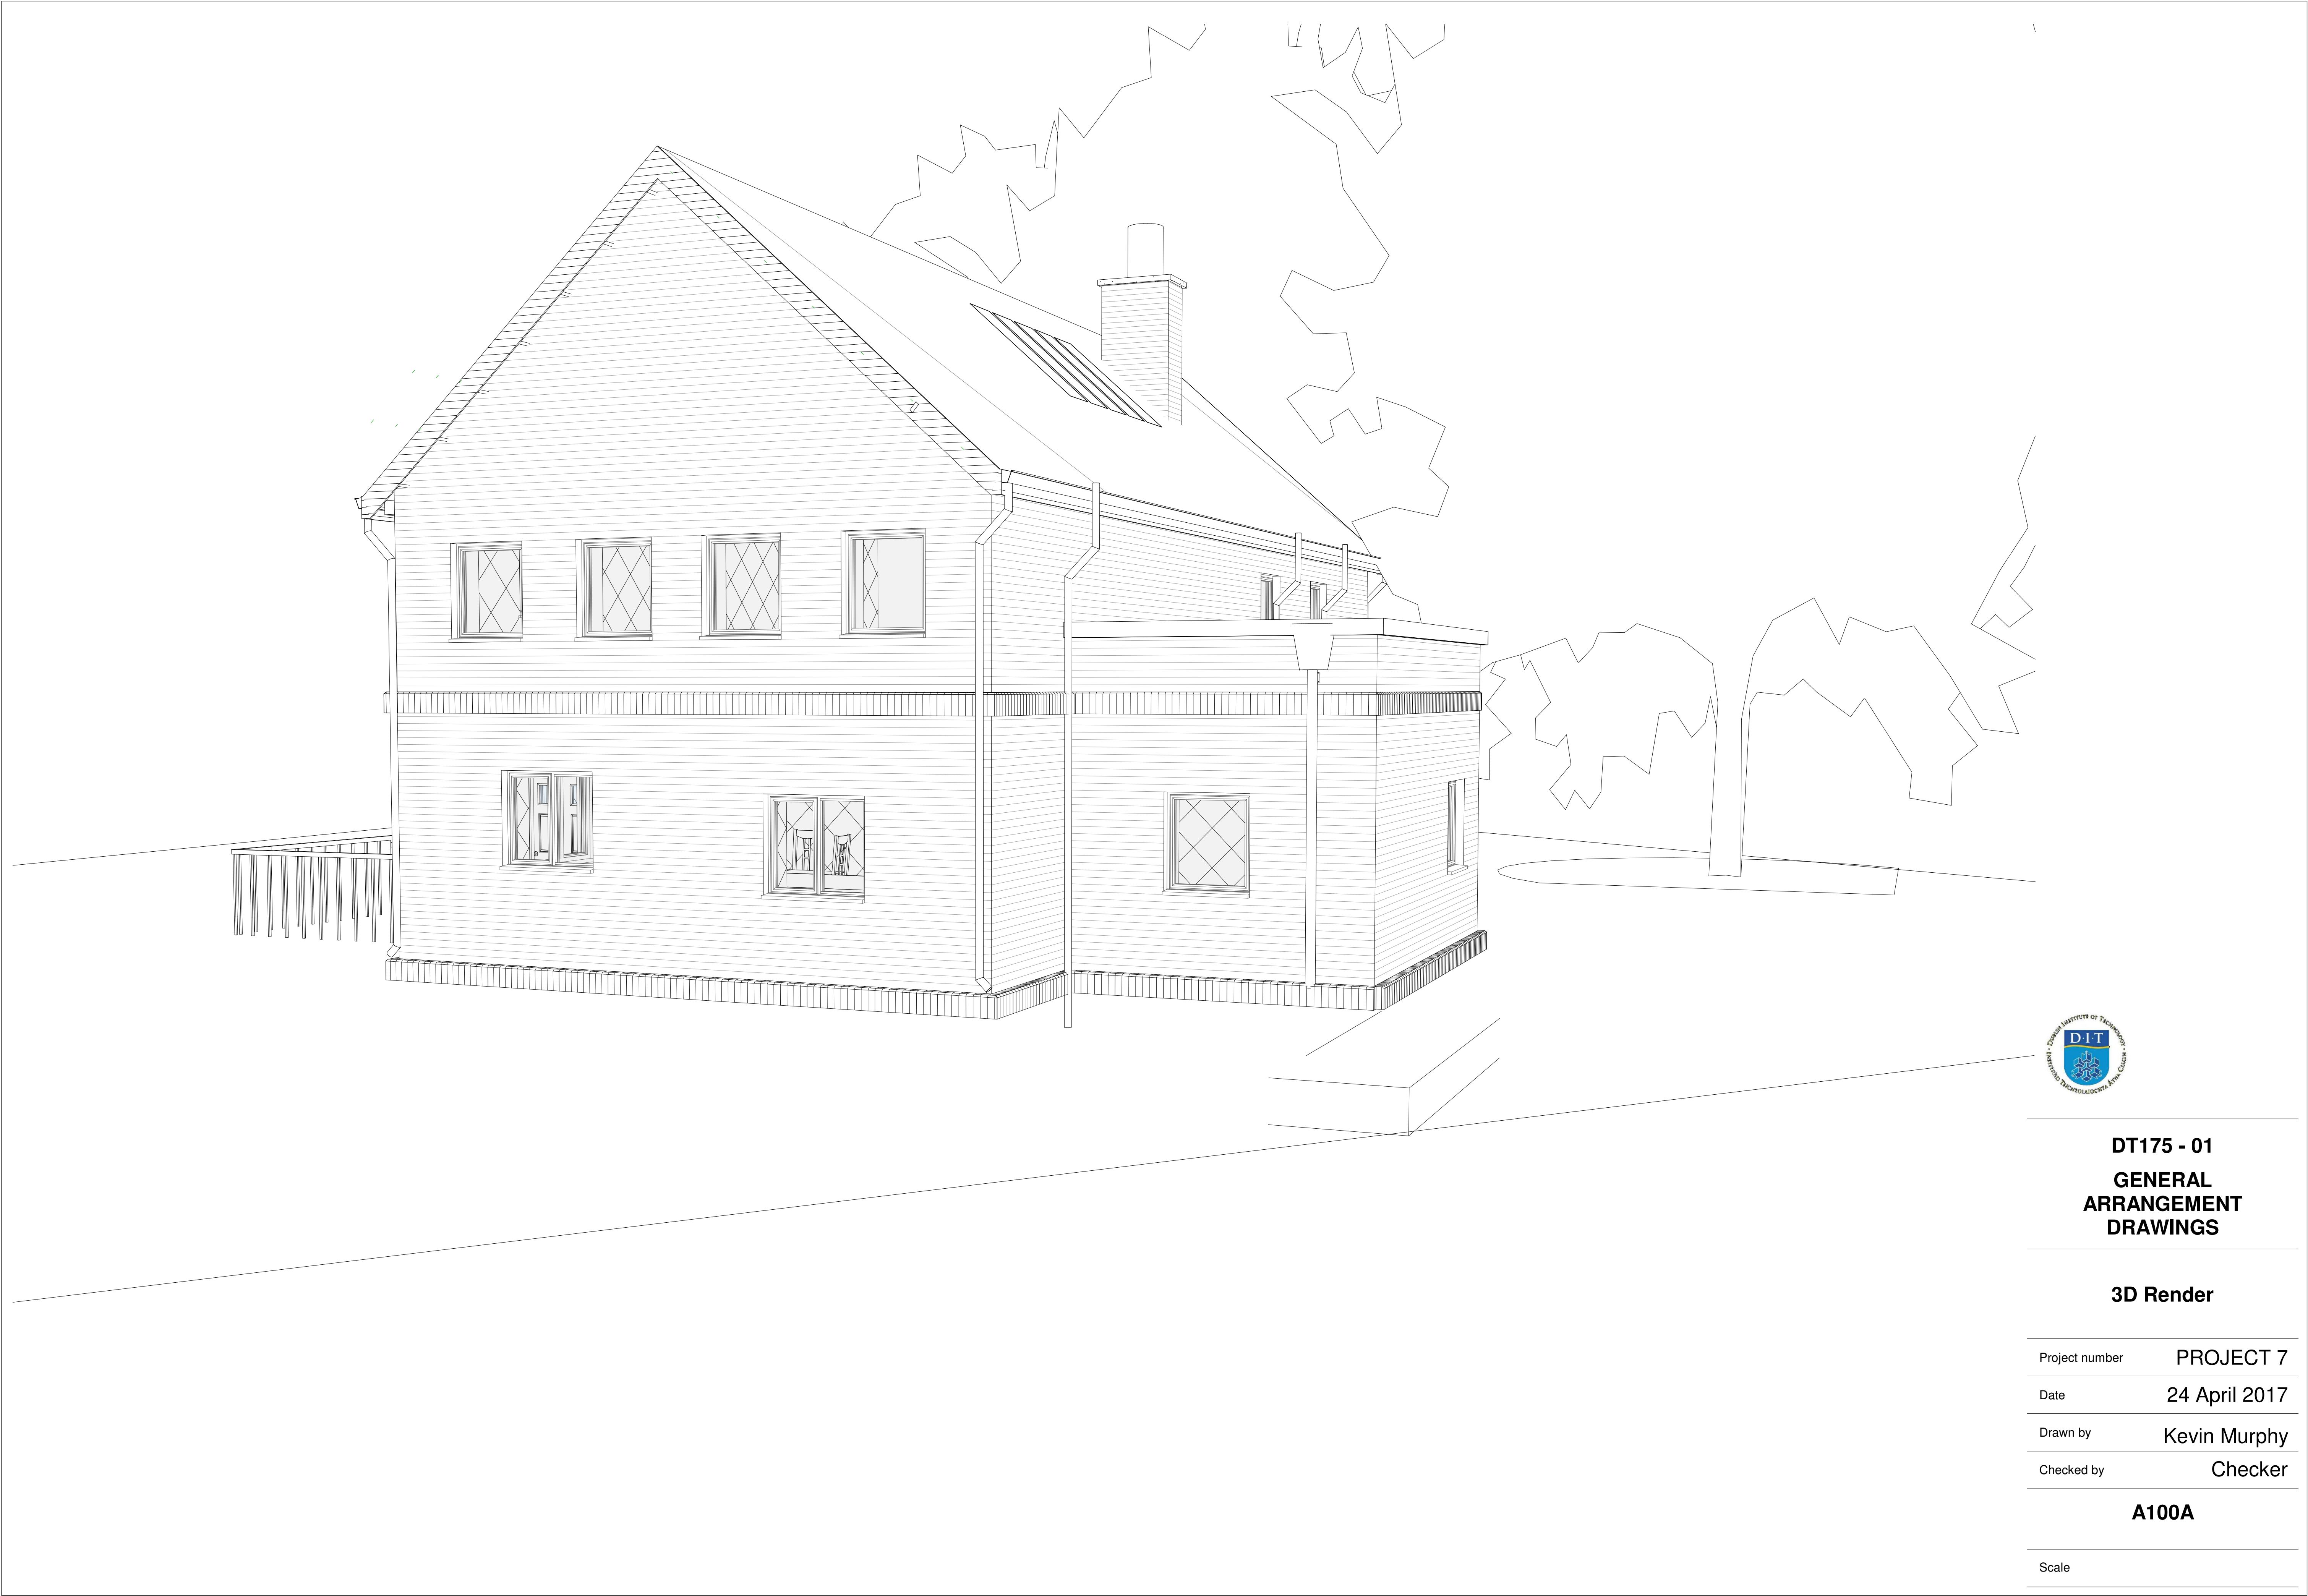

DT175 - 01

GENERAL
ARRANGEMENT
DRAWINGS

3D Render

Project number PROJECT 7

Date 24 April 2017

Drawn by Kevin Murphy

Checked by Checker

A100A

Scale



Consultant
Address
Address
Phone
Fax
e-mail


**DT175-01
GENERAL
ARRANGEMENT
DRAWINGS**


4 Elevations

Project number	PROJECT 7
Date	24 April 2017
Drawn by	Kevin Murphy
Checked by	Checker

A102

Scale	1 : 50
-------	--------

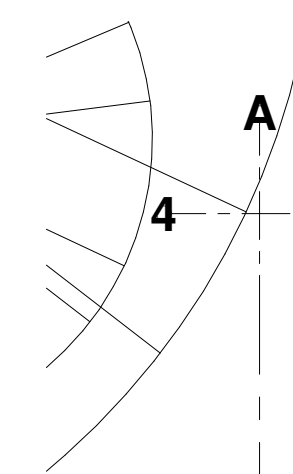

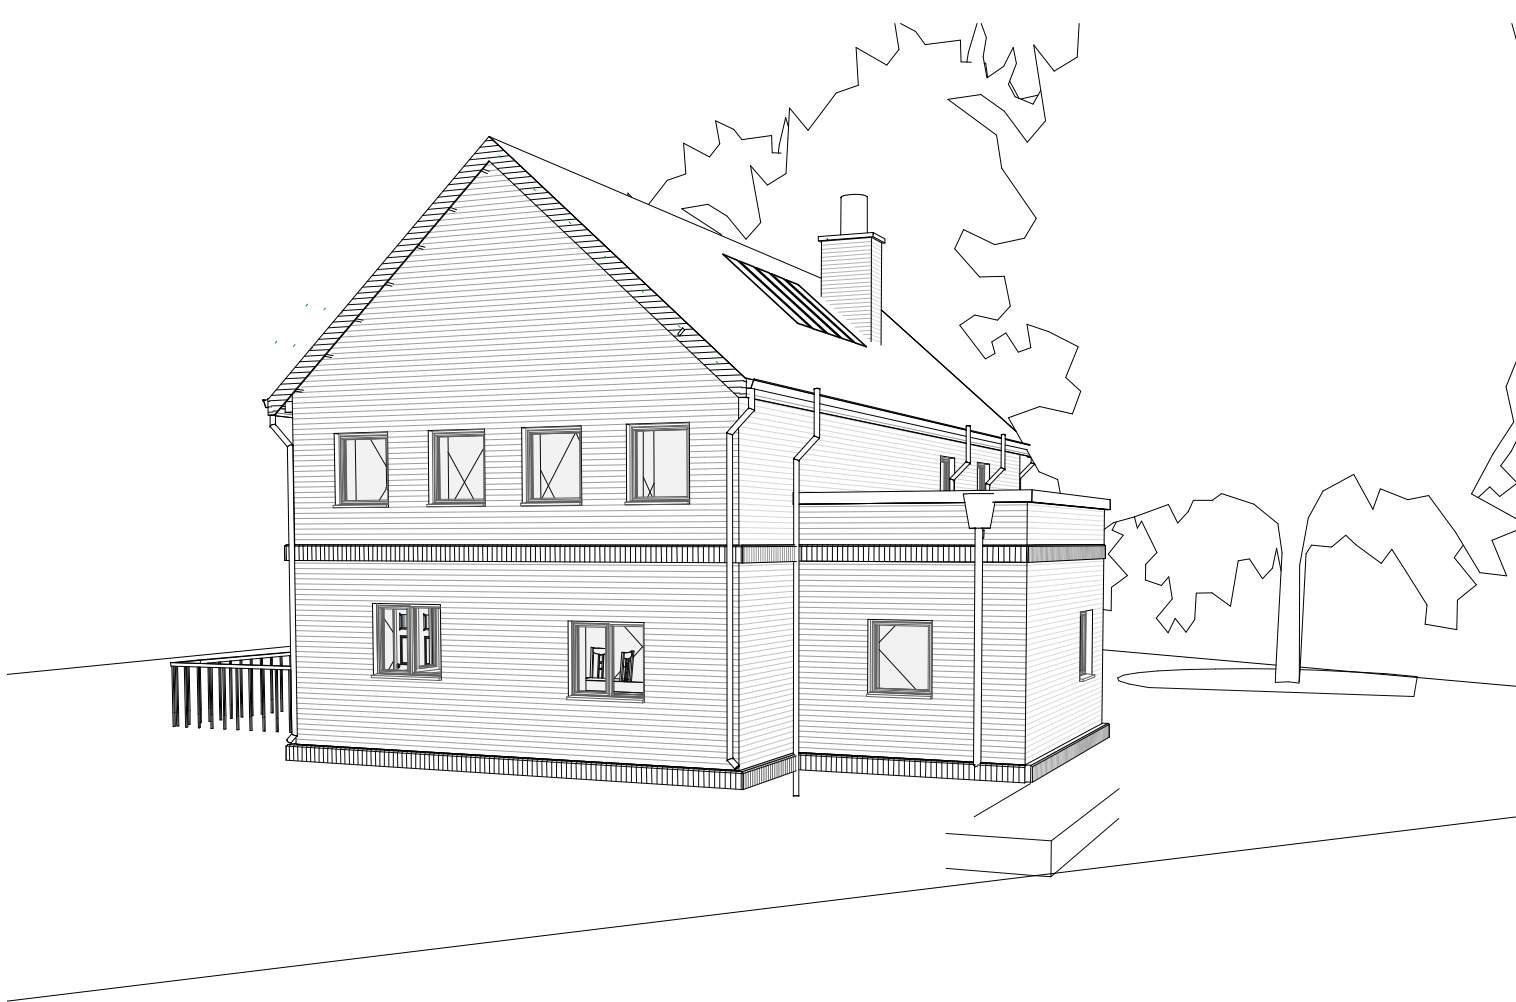



DT175 - 01
GENERAL
ARRANGEMENT
DRAWINGS

House Views

Project number	PROJECT 7
Date	24 April 2017
Drawn by	Author
Checked by	Checker

A104

Scale

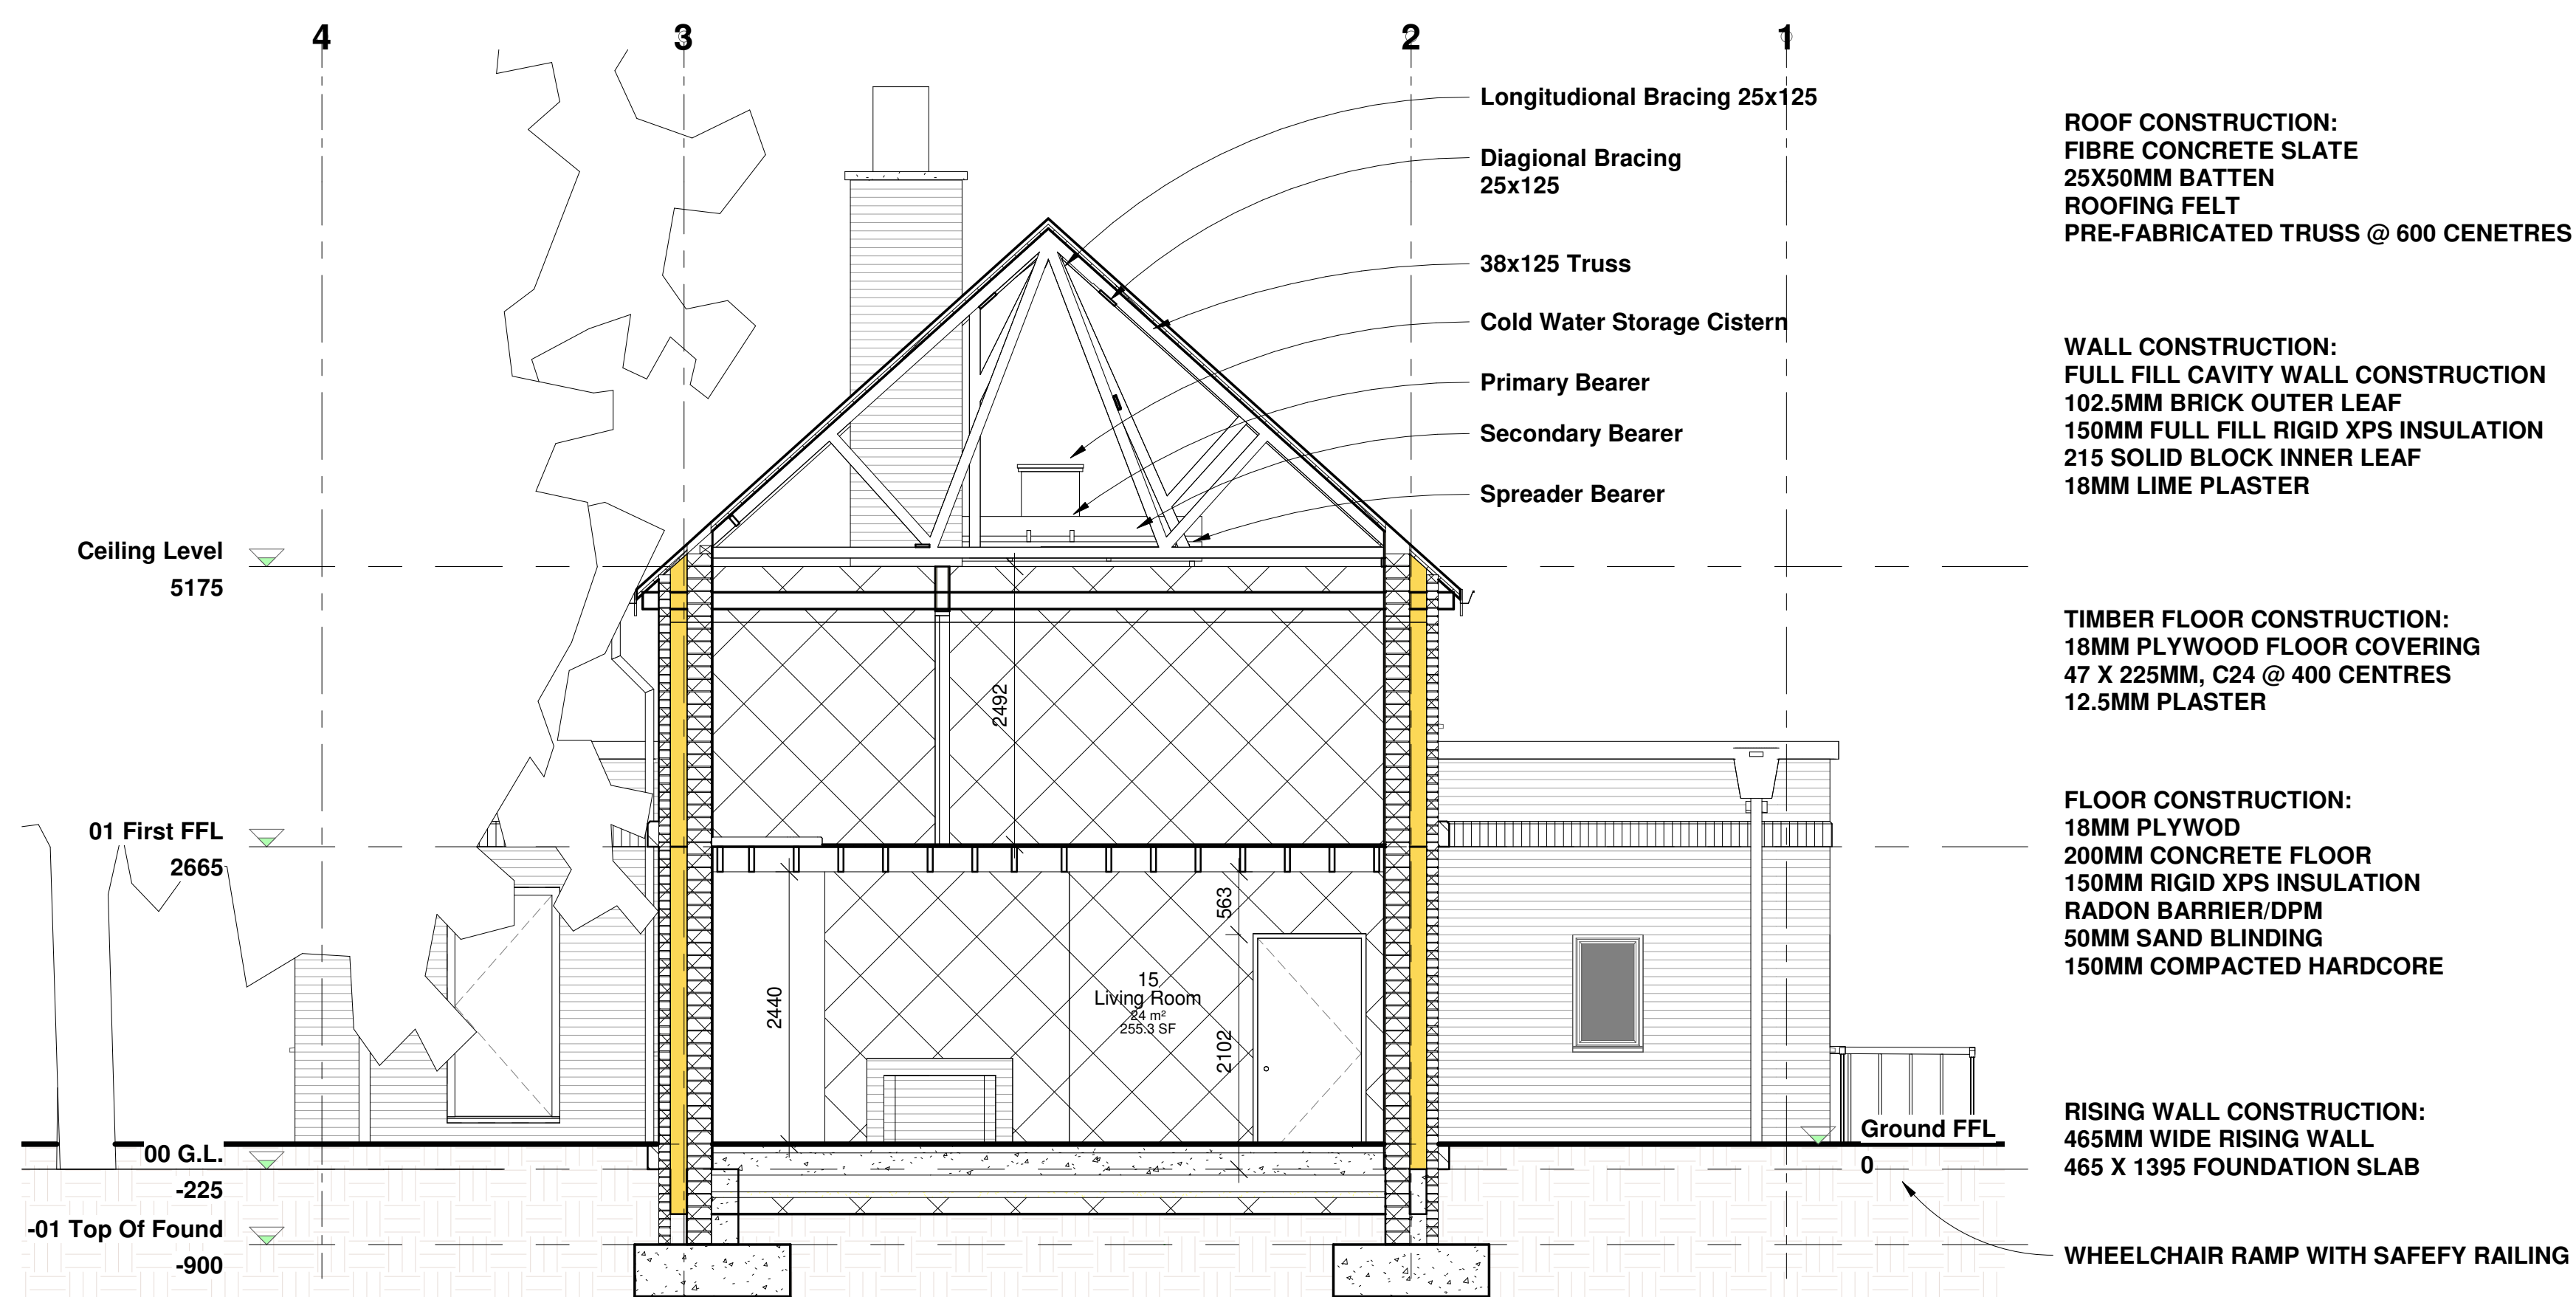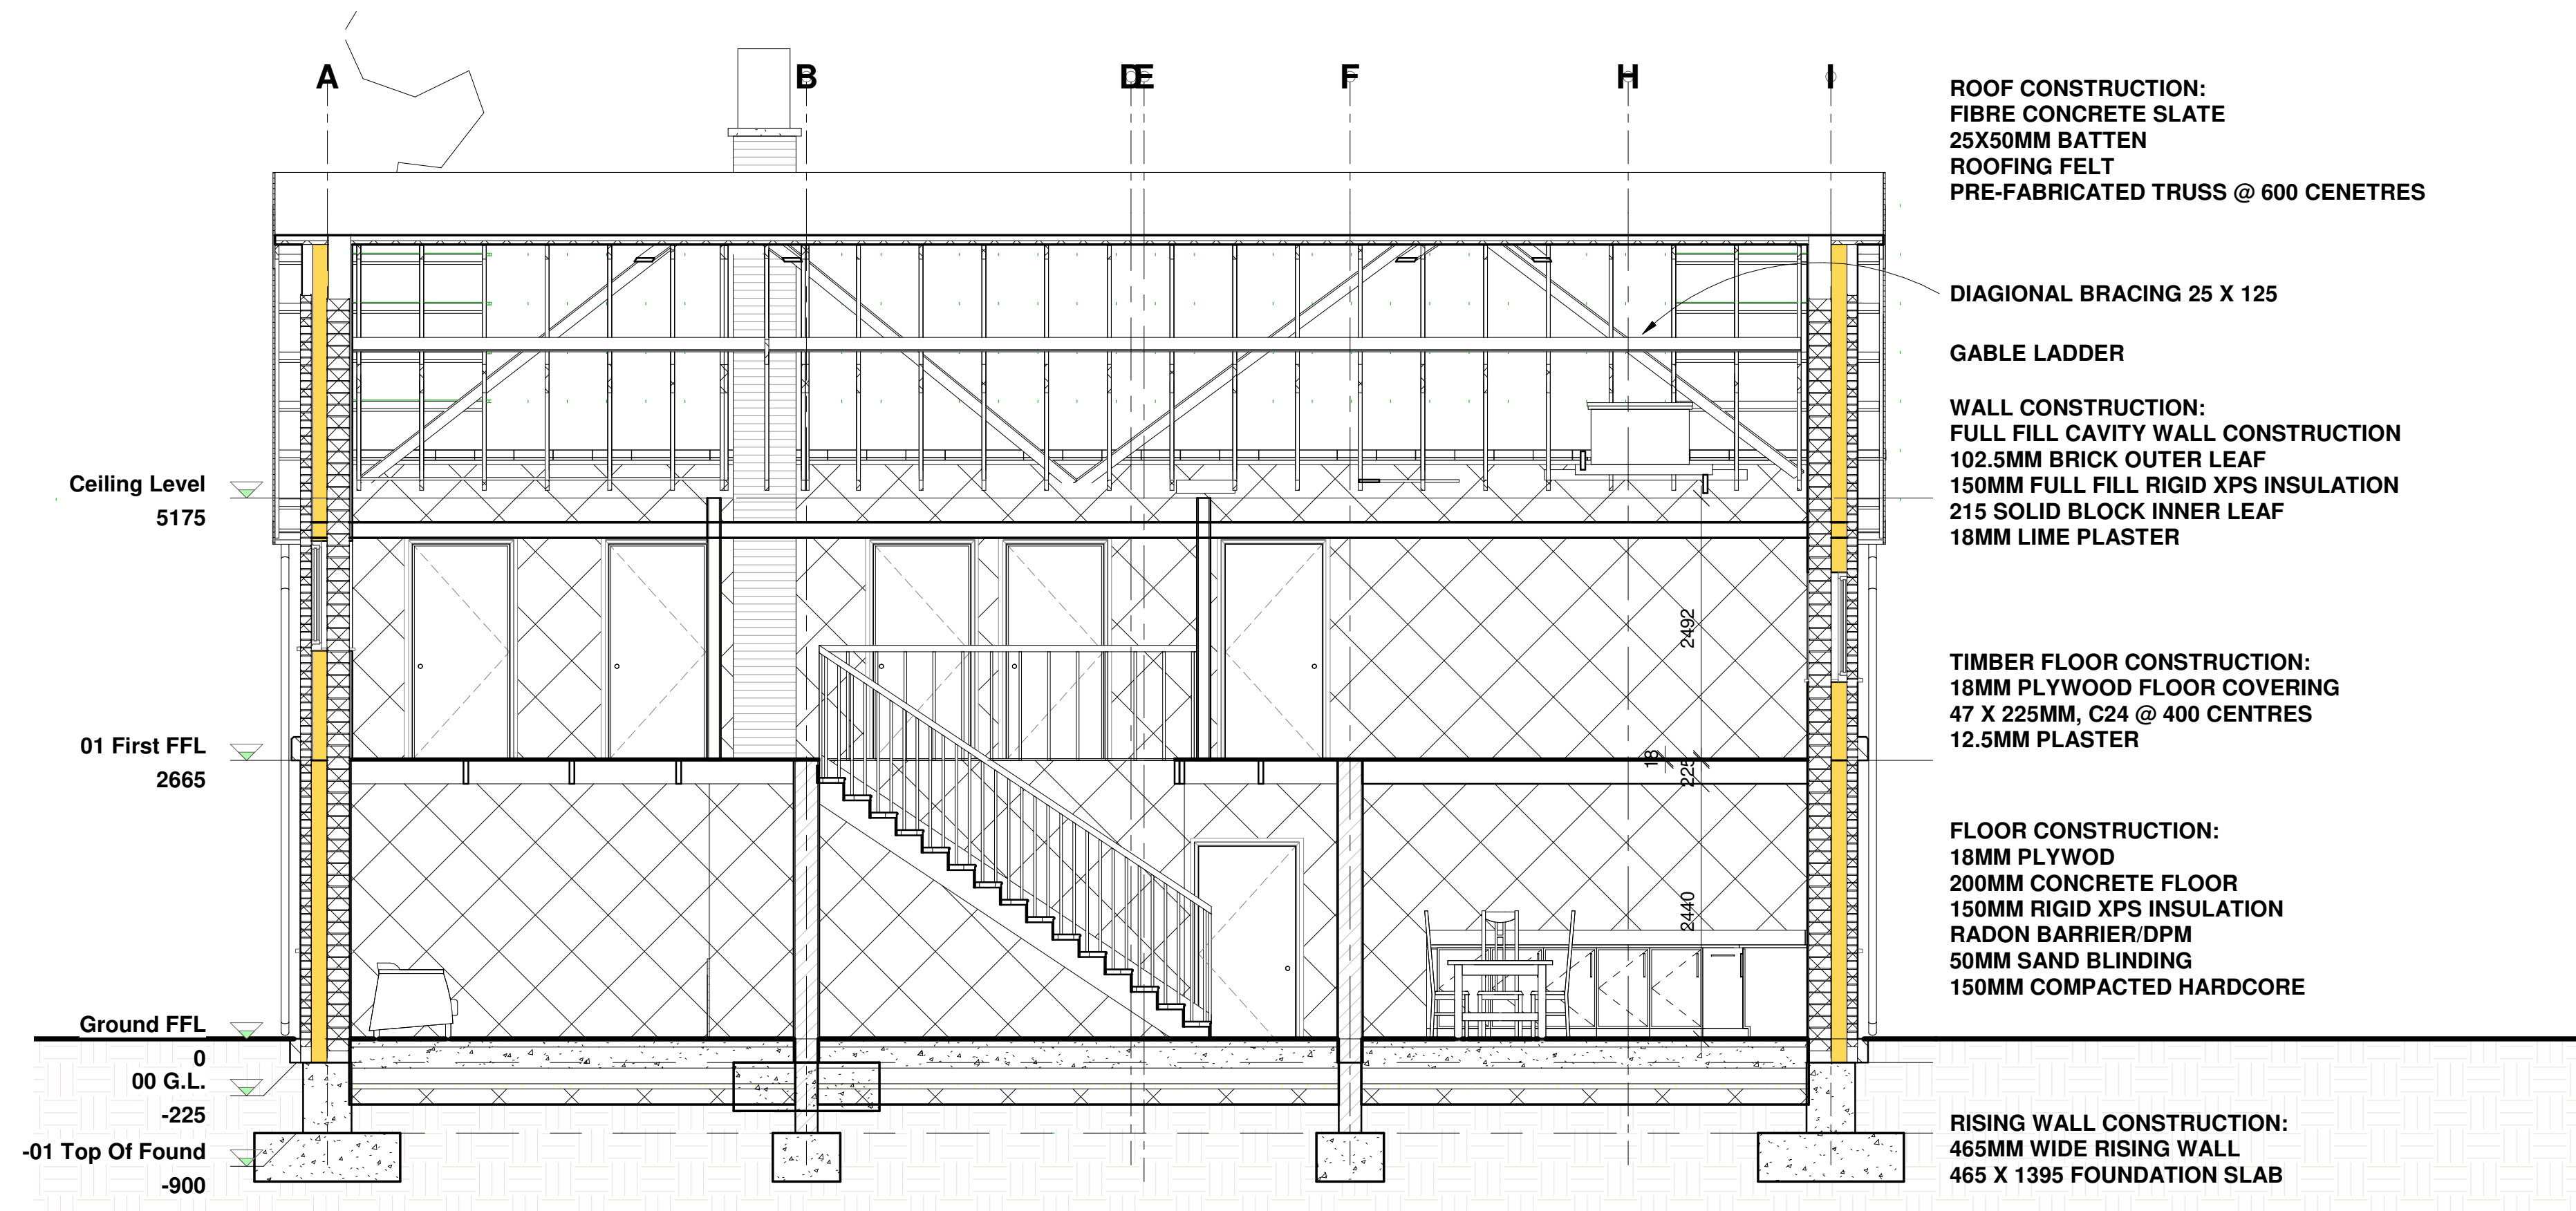


DT175 - 01
GENERAL
ARRANGEMENT
DRAWINGS

Sections

Project number	PROJECT 7
Date	24 April 2017
Drawn by	KEVIN MURPHY
Checked by	

A105 - Sections

Scale	1 : 50
-------	--------

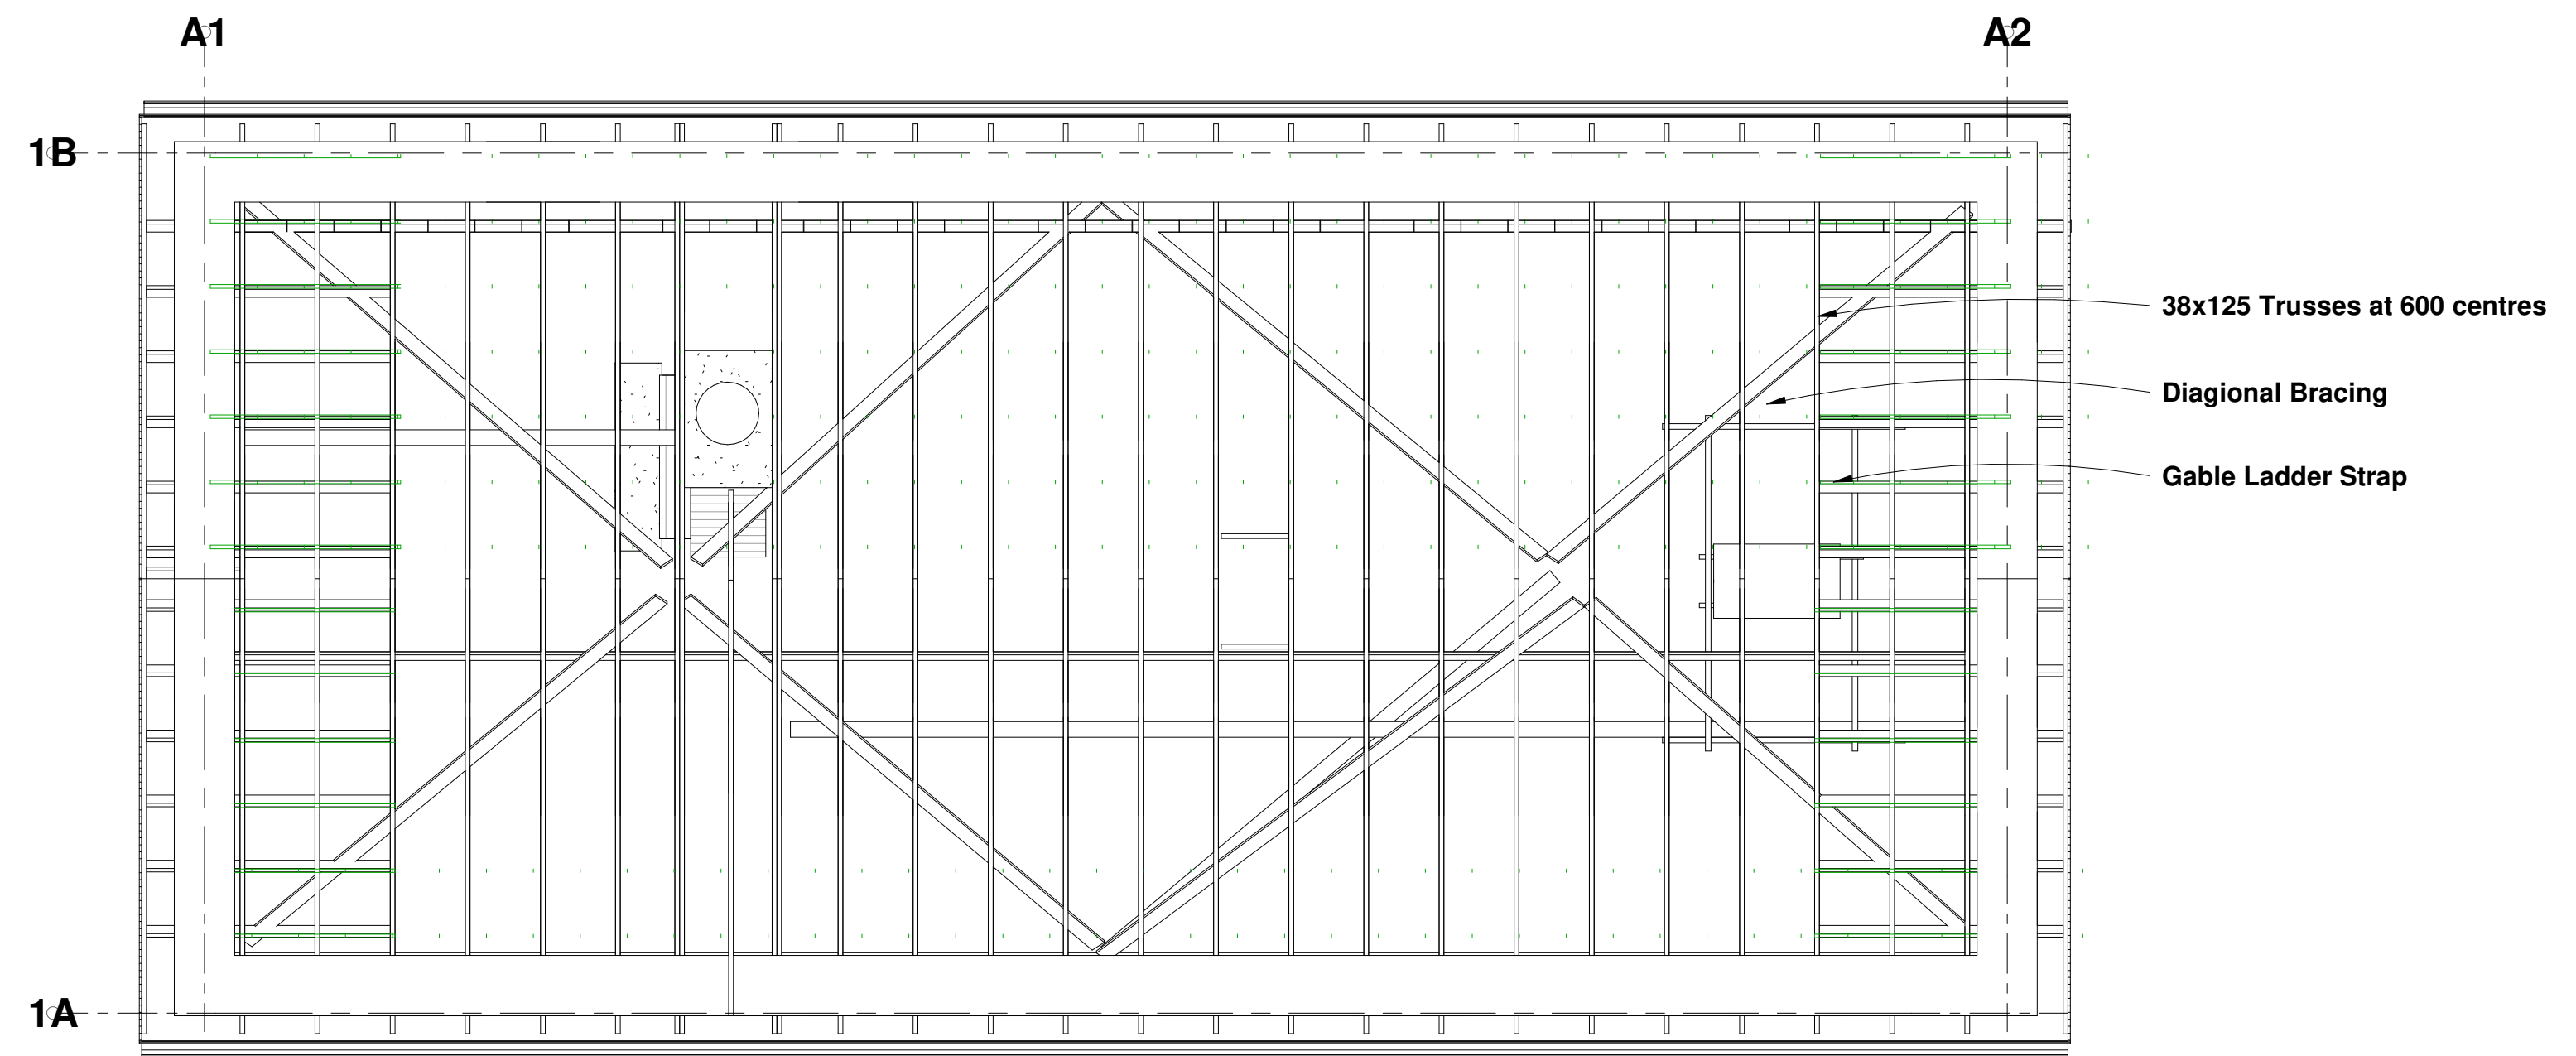

DT175 - 01

GENERAL
ARRANGEMENT
DRAWINGS

Roof Plans

Project number PROJECT 7

Date 24 April 2017

Drawn by Kevin Murphy

Checked by Checker

A106 - Roof Plan

Scale 1 : 50



North



DT175 - 01
GENERAL
ARRANGEMENT
DRAWINGS

Site Plan

Project number PROJECT 7

Date 24 April 2017

Drawn by Kevin Murphy

Checked by Checker

A107

Scale As indicated

Legend					
R.W.P.	Rain Water Pipe				
S.V.P.	Soil Vent Pipe				
A.J.	Armstrong Junction				
M.H.	Man Hole				
G.T.	Gully Trap				
- - -	Surface Water				
- - -	Foul Water				
---	Boundary				

Foul Water	C.L.	I.L.	Surface Water	C.L.	I.L.
A.J. (9)	21.5	20.902	A.J. (1)	21.5	21.025
A.J. (10)	21.5	20.851	A.J. (2)	21.5	20.975
A.J. (11)	21.5	20.568	A.J. (3)	21.5	20.881
			A.J. (4)	21.5	20.831
			A.J. (5)	21.5	20.728
			A.J. (6)	21.5	20.646
			A.J. (7)	21.5	20.551
			A.J. (8)	21.5	20.460